



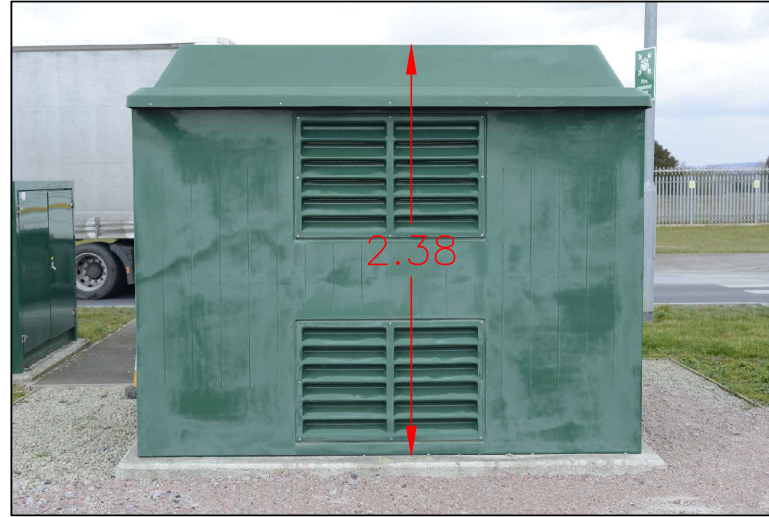

ELEVATION 1

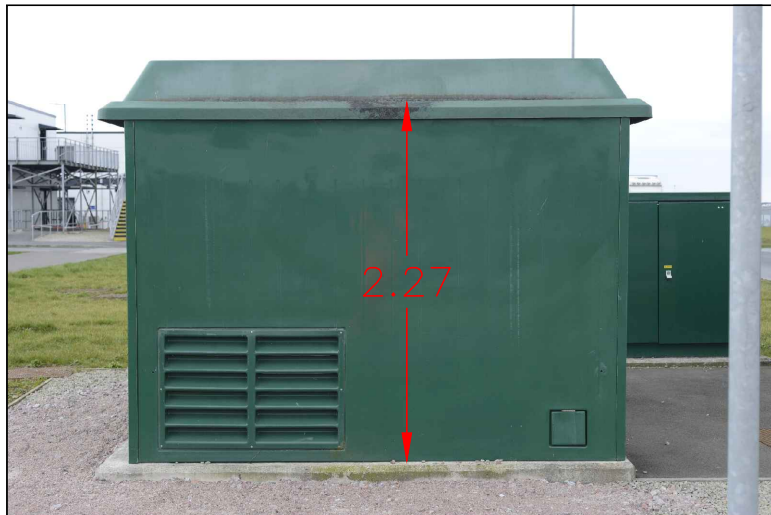

ELEVATION 2




ELEVATION 3



ELEVATION 4

LOCATION PLAN Scale 1:200

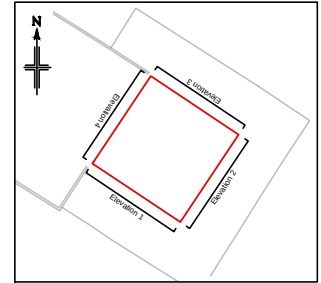

STATUS CODE & REVISIONS

Stat	Rev	Details	Checked 1st 2nd	Date
S3	P01	First Issue	ST IMAG	01/04/25
S3	P02	Second Issue	ST RP	13/06/25

CLIENT

Jones Lang Lasalle Ltd

30 Warwick Street
London
W1B 5NH

PROJECT TITLE

Sevington IBF
Ashford TN25 6GE

Electrical Plant 5 (Substation) -
Photo Elevations

PRESENTATION SCALE Not to Scale @ A4

DATE OF ORIGINAL SURVEY March 2025

PC PROJECT No. 49502 STATUS & REVISION

S3 P02

DRAWING No.
49502-PCL-PH-ZZ-DR-Y-00001_EP5

Plowman Craven

Plowman Craven House
2 Lea Business Park
Lower Luton Road
Harpden
Hertfordshire
AL5 5EQ
Tel: +44 (0)1582 765566
Email: post@plowmancraven.co.uk
Web: www.plowmancraven.co.uk

115 Southwark Bridge Road
London
SE1 0AX

Tel: +44 (0)207 490 7700