



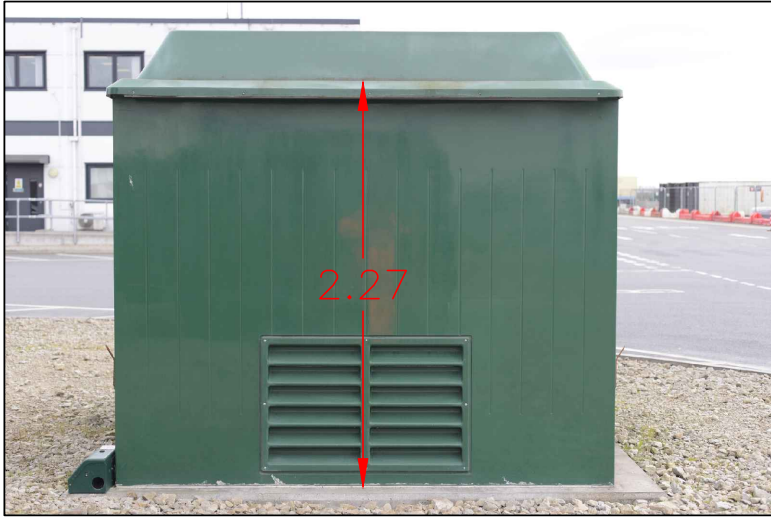

ELEVATION 1

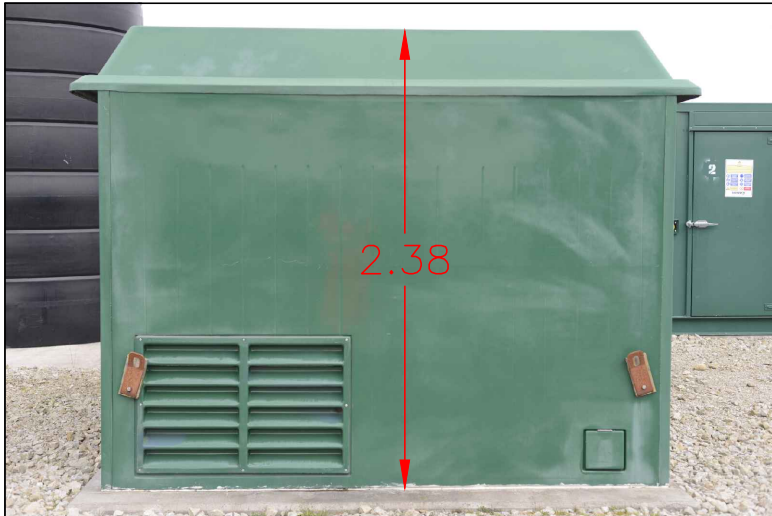

ELEVATION 2



ELEVATION 3



ELEVATION 4

**LOCATION PLAN**  
Scale 1:200

**STATUS CODE & REVISIONS**

Stat	Rev	Details	Checked 1st	2nd	Date
S3	P01	First Issue	ST	M/JG	01/04/25

**CLIENT**  
Jones Lang Lasalle Ltd  
30 Warwick Street  
London  
W1B 5NH

**PROJECT TITLE**  
Sevington IBF  
Ashford TN25 6GE  
Electrical Plant 3 (Substation) -  
Photo Elevations

**PRESENTATION SCALE** Not to Scale @ A4

**DATE OF ORIGINAL SURVEY** March 2025  
**PC PROJECT No.** 49502 **STATUS & REVISION**  
S3 P01

**DRAWING No.**  
49502-PCL-PH-ZZ-DR-Y-00001\_EP3

**Plowman Craven**  
Plowman Craven House  
2 Lea Business Park  
Lower Luton Road  
Harpenden  
Hertfordshire  
AL5 5EQ  
Tel: +44 (0)1582 765566  
Email: post@plowmancraven.co.uk  
Web: www.plowmancraven.co.uk

115 Southwark Bridge Road  
London  
SE1 0AX  
Tel: +44 (0)207 490 7700

© PLOWMAN CRAVEN LIMITED  
NOT TO BE REPRODUCED WITHOUT PERMISSION